

HILBERS
CONTRACTORS
& ENGINEERS

1104 CORPORATE WAY
SUITE 204
SACRAMENTO, CA 95831
TEL: 916-429-3246 FAX:
916-429-3241

STAMP/REVIEWER:

DESIGNER:



7028 SUNRISE BLVD. SUITE 211
CITRUS HEIGHTS, CA 95610
PHONE: 916-242-0259
WWW.FIRE101.NET




These drawings are prepared under my supervision for the exclusive use of Hilbers Inc. no use or duplication of these drawings is permitted without the prior written consent of Hilbers Inc.

NOT FOR CONSTRUCTION
WITHOUT PRIOR
AHJ APPROVAL




**BANK OF FEATHER RIVER
MANUAL FIRE ALARM SYSTEM**

1280 BRIDGE STREET
YUBA CITY, CA 95991

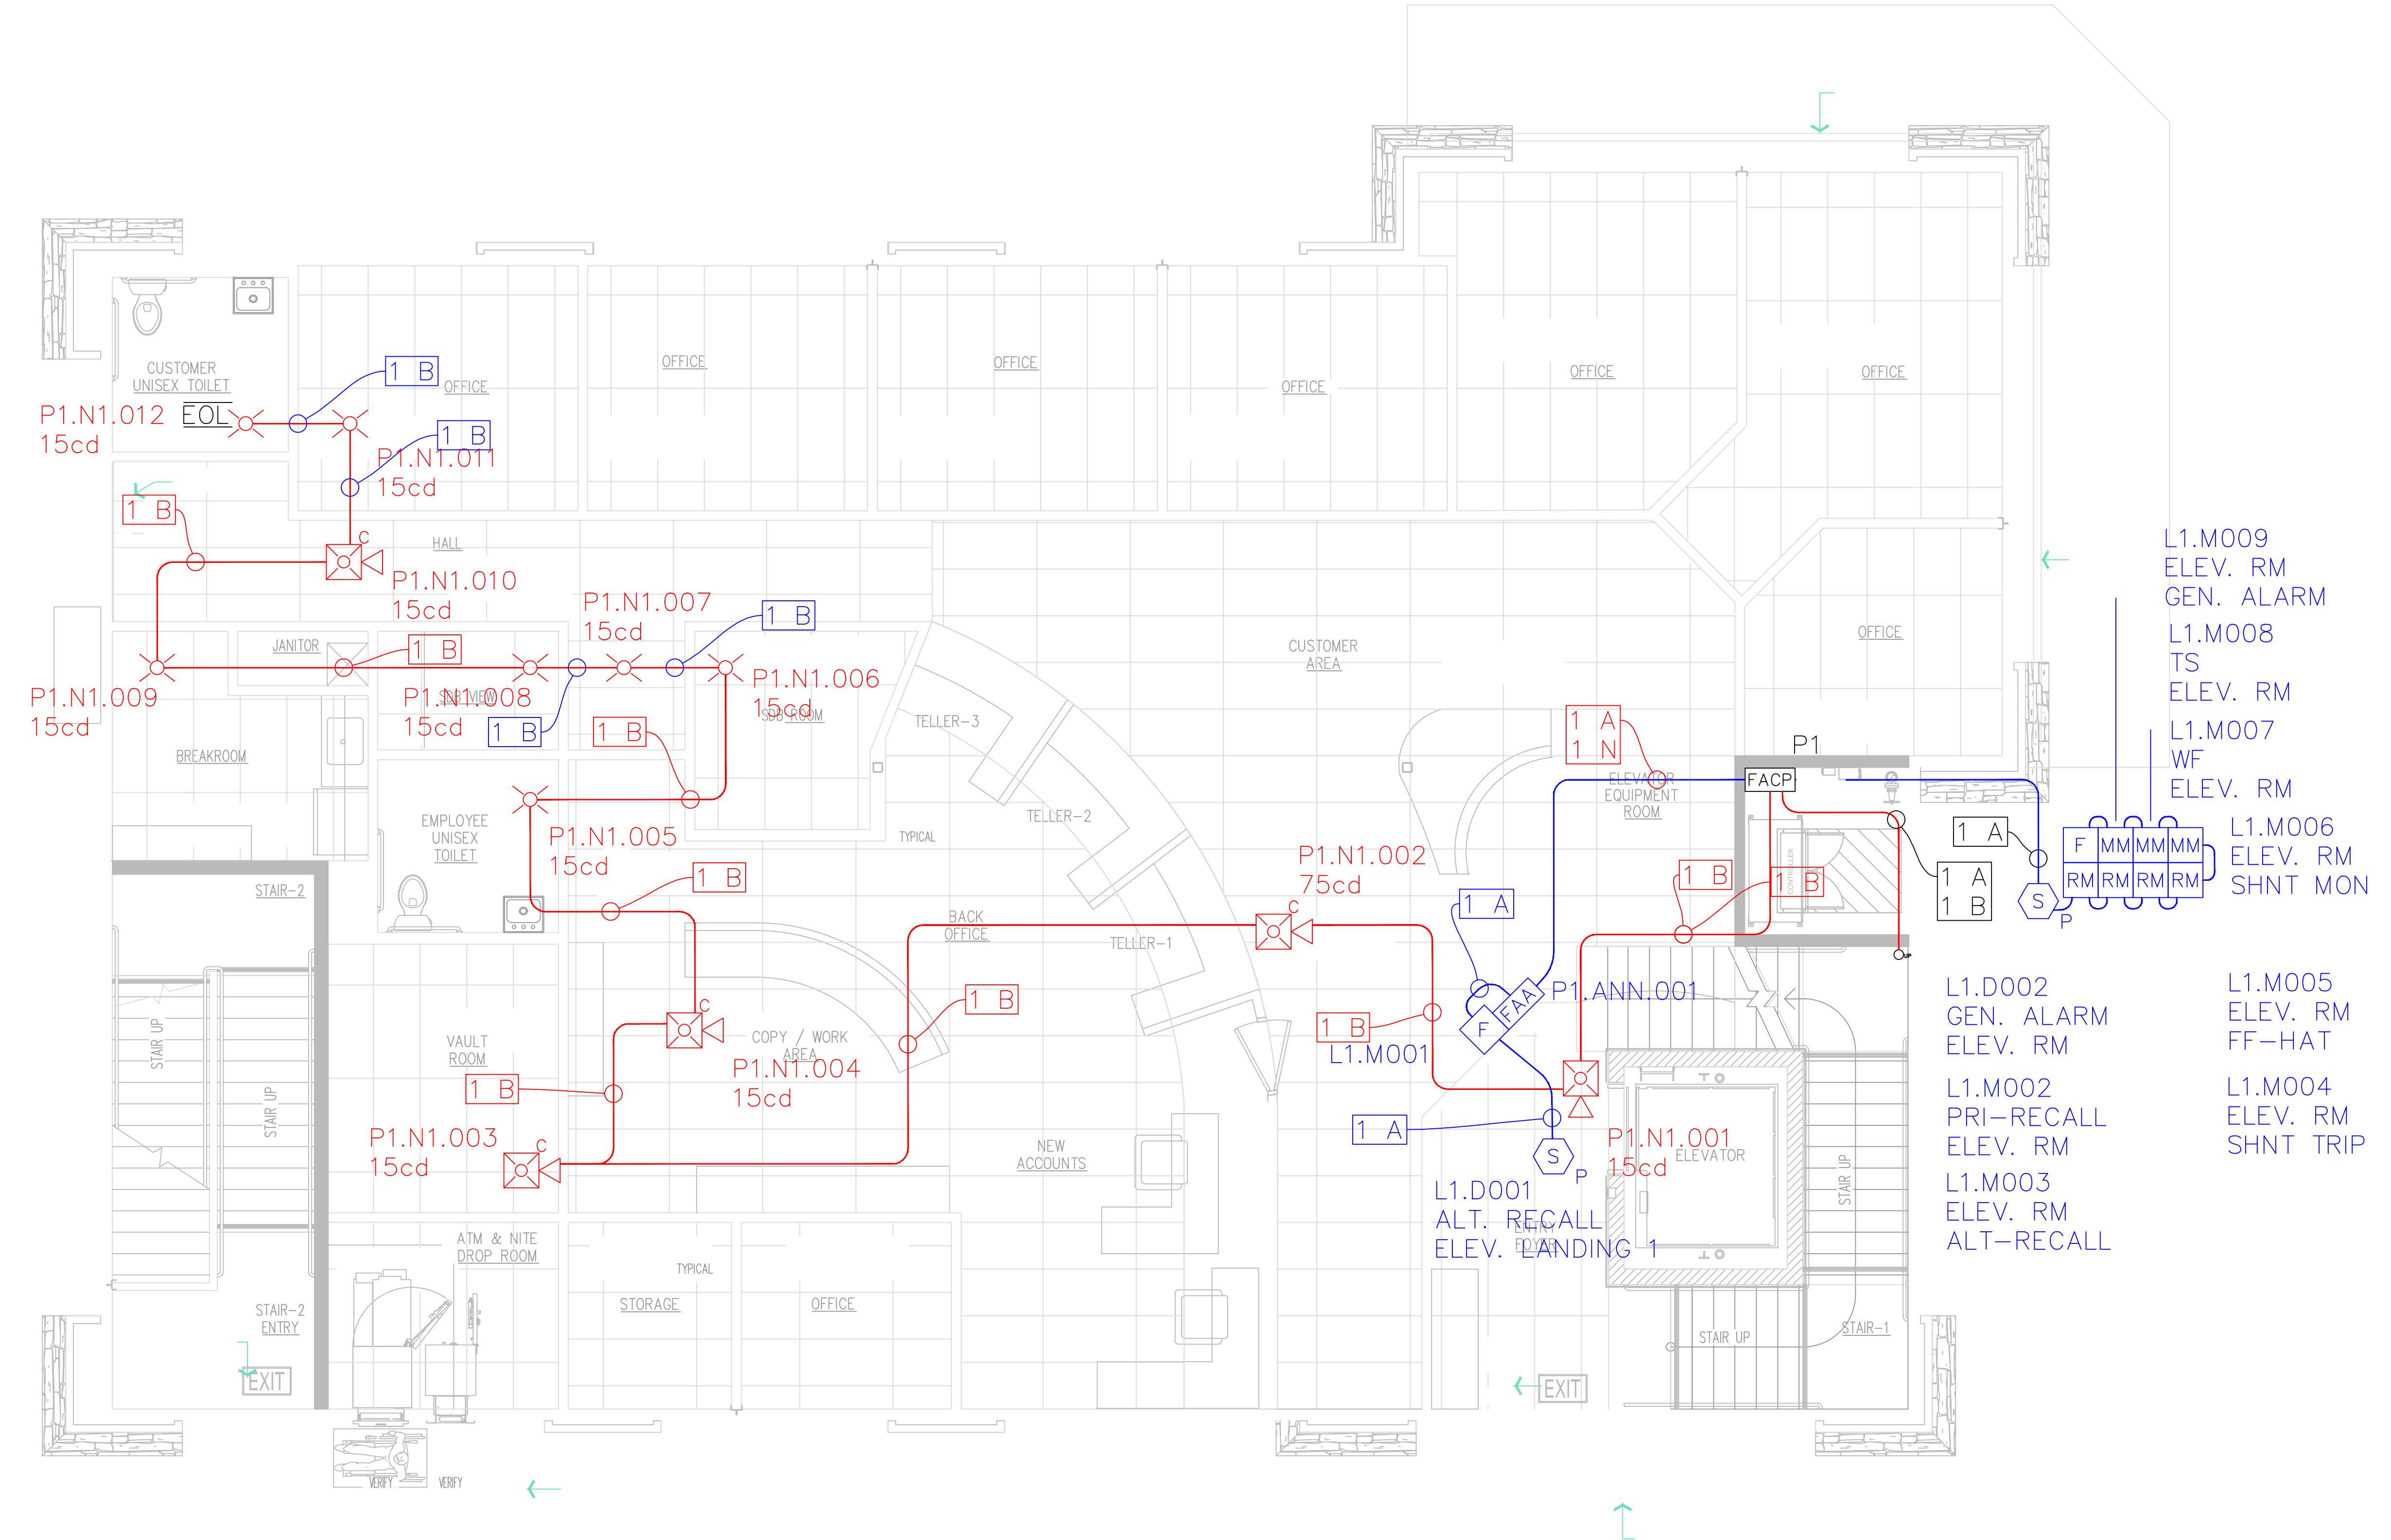

FIRE ALARM SYSTEM PLAN, LEVEL 1
SCALE: 1/4" = 1'-0"

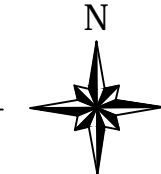

REVISIONS

△	SUBMITTAL 11/30/17
△	
△	
△	

DRAWN BY:
RS

CHECKED BY:
JC

JOB#
TBD

FILE #
17132

SCALE:
AS SHOWN

DATE:
11/10/17

DRAWING NO.