

HILBERS
CORPORATE
CONTRACTORS
& ENGINEERS

1104 CORPORATE WAY
SUITE 204
SACRAMENTO, CA 95831
TEL: 916-429-3246 FAX:
916-429-3241

STAMP/REVIEWER:

DESIGNER:



7628 SUNRISE BLVD. SUITE 211
CITRUS HEIGHTS, CA 95610
PHONE: 916-242-0259
WWW.FIRE101.NET




These drawings are prepared under my supervision for
the exclusive use of Hilbers Inc. no use or duplication of
these drawings is permitted without the prior written
consent of Hilbers Inc.

NOT FOR CONSTRUCTION
WITHOUT PRIOR
AHJ APPROVAL



BANK OF FEATHER RIVER
MANUAL FIRE ALARM SYSTEM
1280 BRIDGE STREET
YUBA CITY, CA 95991

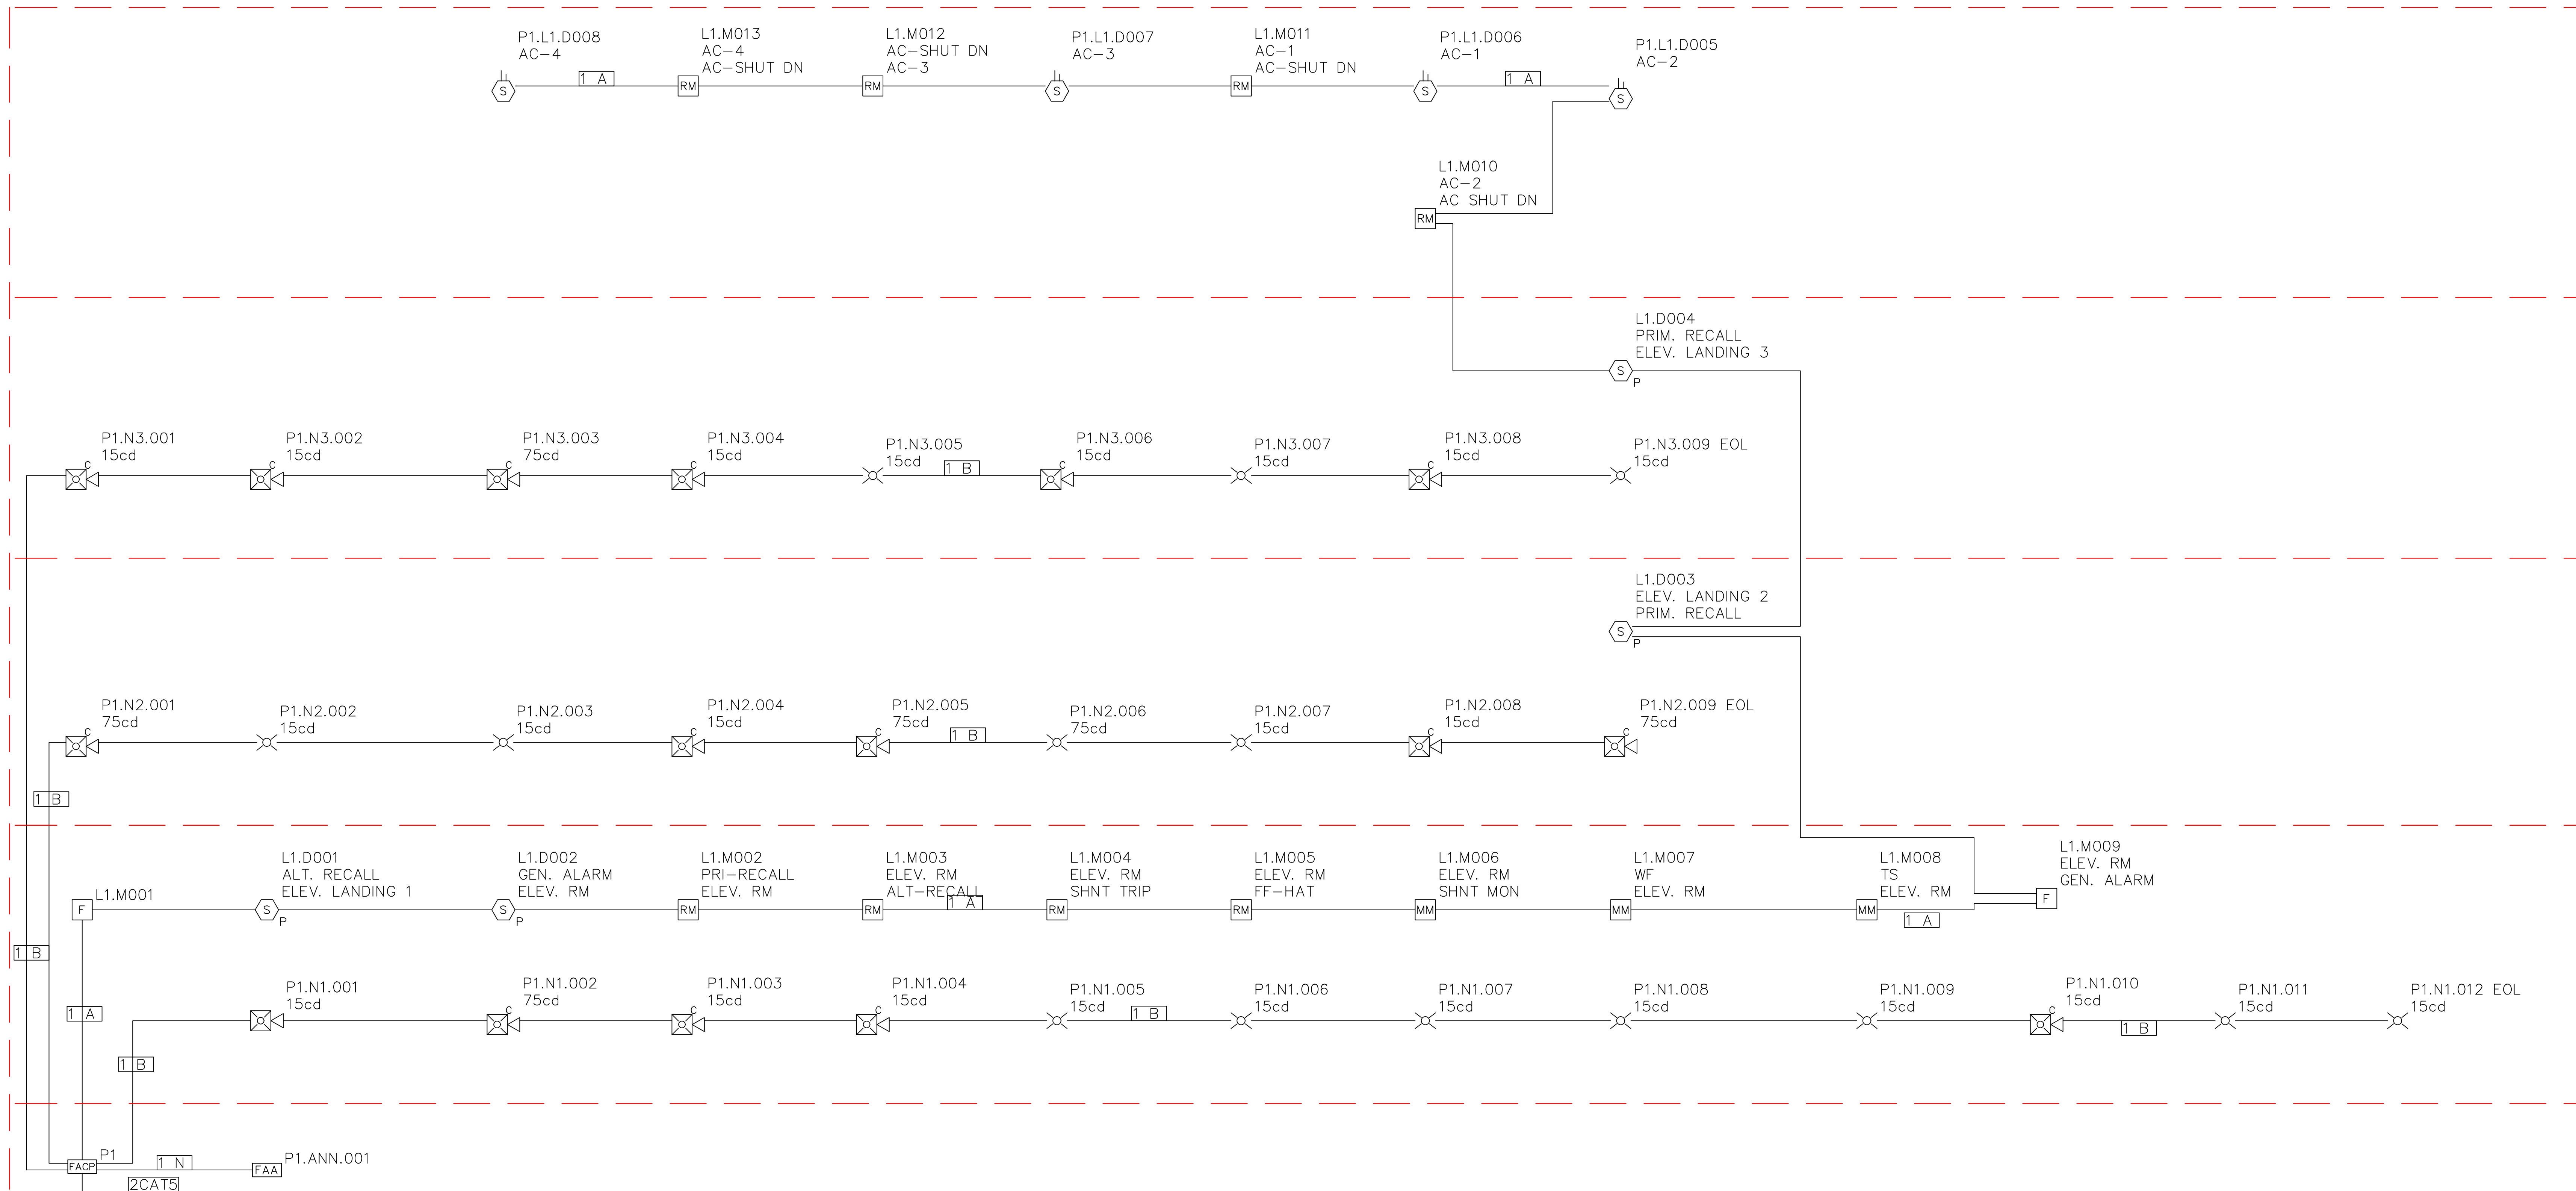

FIRE ALARM SYSTEM RISER DIAGRAM
SCALE: NONE

REVISIONS	
△	SUBMITTAL 11/30/17
△	
△	
△	
△	

DRAWN BY: RS
CHECKED BY: JC
JOB# TBD
FILE # 17132
SCALE: AS SHOWN
DATE: 11/10/17
DRAWING NO.

IF THIS SHEET DOES NOT MEASURE TO BE 30" X 42", IT IS A REDUCED PRINT.